


FLOOR PLAN

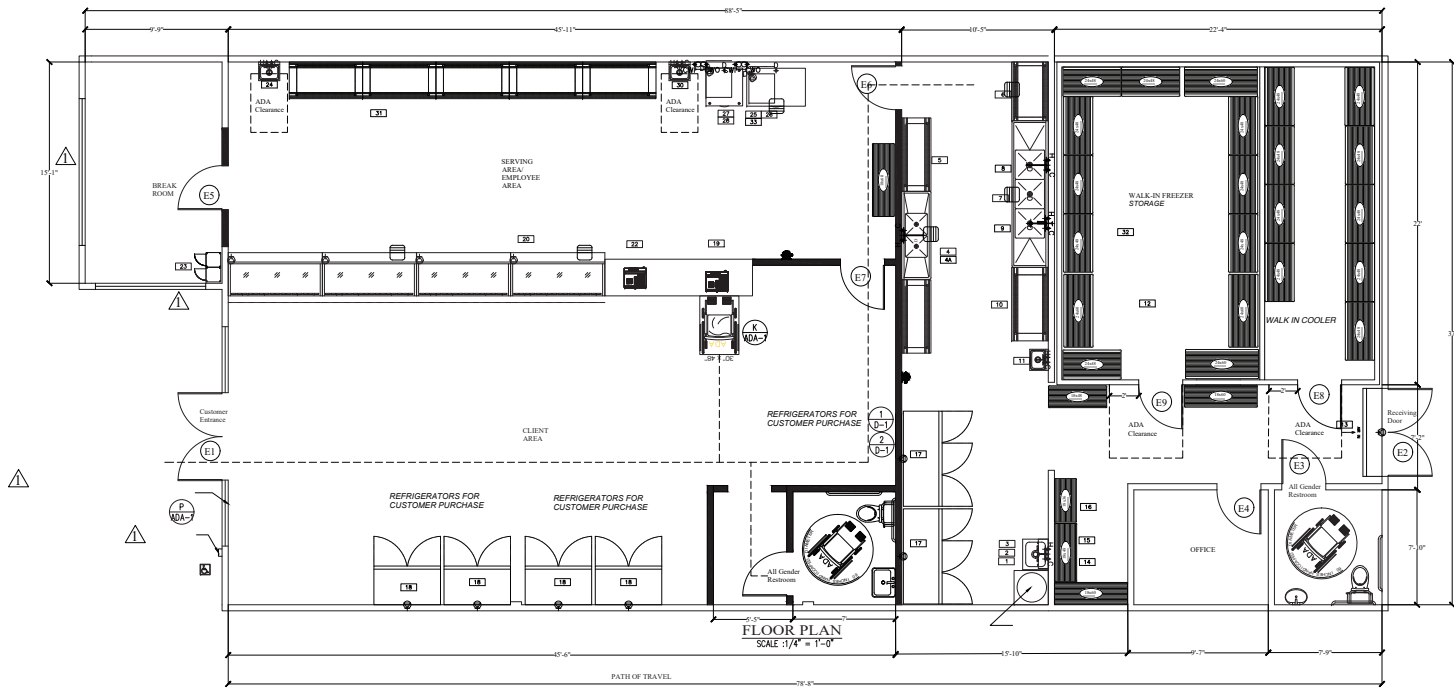

Finish Schedule				
AREA	FLOOR	COVE BASE	WALL FINISHES	CEILING
Kitchen	Concrete Slab w/ 2" Surface Concrete Base	Quarry Tile 6" Cove Base	Acrylic Solid 6" Base	Acrylic Solid 6" Base
	Quarry Tile 6" Cove Base	Acrylic Solid 6" Base	Acrylic Solid 6" Base	Acrylic Solid 6" Base
	Acrylic Solid 6" Base	Acrylic Solid 6" Base	Acrylic Solid 6" Base	Acrylic Solid 6" Base
	Acrylic Solid 6" Base	Acrylic Solid 6" Base	Acrylic Solid 6" Base	Acrylic Solid 6" Base
Break Room	Quarry Tile 6" Cove Base	Quarry Tile 6" Cove Base	Acrylic Solid 6" Base	Acrylic Solid 6" Base
Client Area	Quarry Tile 6" Cove Base	Quarry Tile 6" Cove Base	Acrylic Solid 6" Base	Acrylic Solid 6" Base
Restrooms	Quarry Tile 6" Cove Base	Quarry Tile 6" Cove Base	Acrylic Solid 6" Base	Acrylic Solid 6" Base
Walk-in Cooler	Quarry Tile 6" Cove Base	Quarry Tile 6" Cove Base	Acrylic Solid 6" Base	Acrylic Solid 6" Base
Map Sink	Quarry Tile 6" Cove Base	Quarry Tile 6" Cove Base	Acrylic Solid 6" Base	Acrylic Solid 6" Base
Prep Area	Quarry Tile 6" Cove Base	Quarry Tile 6" Cove Base	Acrylic Solid 6" Base	Acrylic Solid 6" Base
Notes:	FRP Lining to be applied behind test areas, extended min 18" on each side. All walls and ceiling to have a smooth finish and light to color with 70% light reflective value (L.R.V.). Trunk Enclosure to have smooth and washable walls and floor.			

EQUIPMENT SCHEDULE														
Item No	Qty	Equipment Category	Manufacturer	Model Number	Amps	Volts	HP	Phase	Frequency	Control	Plug	NEMA	Wiring	Notes
1	1	Sink, Map	Aluminum Tubing	9-09-05										
2	1	Faucet, Service Sink	Fisher	B283										
3	1	Shelf, Wall Mount	Aluminum Tubing	K-245										
4	1	Sink, Kitchen	Turbo Air	15A-2-12-01										
4a	1	Faucet, Backsplash Mount	Fisher	13218										
5	2	Table, Work	Turbo Air	15A-2-12-01										
6	1	Table, Work	Turbo Air	15A-2-12-01										
7	1	Sink, NSF, 3 comp, 16 gauge	OSW	SH24243D										
8	1	Faucet, Backsplash Mount	Fisher	13218										
9	1	Pre-Rinse Faucet, Wall Mount	Fisher	34355										
10	1	Table, Work	Turbo Air	15A-2-12-01										
11	1	Hand Sink, Wall Mount	Aluminum Tubing	7-PS-05										
12	1	Shelving, Wire	Quantum Foodservice	2440P										
13	1	Air Curtains, Unheated	Henry Air Systems	HV775-31P	18.0	115	1	40	1					
14	1	Shelving, Wire	Quantum Foodservice	1860C										
15	1	Shelving, Wire	Quantum Foodservice	1840C										
16	1	Shelving, Wire	Quantum Foodservice	1840C										
17	2	Refrigerator, Reach-in	Aluma USA	MPR800GR	4.2	0.2	115	1	40					
18	4	Freezer, Reach-in, Glass Door	Aluma USA	MPR700GR	8.4	0.8	115	1	40					
19	1	Cash register	By Owner											
20	4	Dell Core, Refrigerated	Henry Pro Cold	MCSC ROW	14.2	0.8	120	1	40	1				
21	2	Cash register	By Owner											
22	2	Locker	OSW	ELS-60R										
23	1	Hand Sink, Wall Mount	Aluminum Tubing	7-PS-05										
24	1	Bin, Ice	Ice-O-Matic	B110PS										
25	1	Ice Maker, Flake Style	Ice-O-Matic	MP0800A	21.0	115	1	40	1					
26	1	Bin, Ice	Ice-O-Matic	B110PS										
27	1	Ice Maker, Flake Style	Ice-O-Matic	MP0800A	21.0	115	1	40	1					
28	1	Hand Sink, Wall Mount	Aluminum Tubing	7-PS-05										
29	1	Table, Work	Turbo Air	15A-2-12-01										
30	1	Walk-in Cooler box	Refrigeration Super store	Custom										
31	1	Filter System, Ionizer	Ice-O-Matic	F02										

FIRE EXTINGUISHER
Type ABC
Classification 2-A:10-B:C
Type A Size 11
Type B-C Size 2

The final number and location of all fire extinguishers shall be determined by the local fire inspector.



REVISIONS	
DATE:	BY:
Rev 10/25/21	Jamie
Rev 10/25/21	Jamie

Tres Island Seafood
12125 Day St Suite T-101
Moreno valley Ca



DATE: 6/25/21

J & L Design
18551 Olalee way
Apple Valley Ca 92307

NOTICE: The final number and location of all fire extinguishers shall be determined by the local fire inspector. The final number and location of all fire extinguishers shall be determined by the local fire inspector.

DATE: 6/25/21

SCALE: 1/4" = 1'-0"

DRAWN: Jamie

JOB: TESL-0621

SHEET:

A-1